

**GENERAL NOTES**

DO NOT SCALE FROM DRAWINGS. WORK TO FIGURED DIMENSIONS ONLY. ARCHITECT TO BE NOTIFIED OF ANY DISCREPANCIES.  
THIS DRAWING TO BE READ IN CONJUNCTION WITH ALL ARCHITECT'S DRAWINGS, SPECIFICATIONS CONSULTANTS DESIGN TEAM DRAWINGS AND SPECIFICATIONS.

**NOTES:**


PLEASE REFER TO MALONE O'NEILL CONSULTING ENGINEERS FOR ALL STRUCTURAL DRAWINGS AND DETAILS  
PLEASE REFER TO SEMPLE MCKILLOP CONSULTING ENGINEERS DRAWINGS FOR ALL MECHANICAL & ELECTRICAL DETAILS FOR THE FOLLOWING:  
- All proposed Mechanical Ventilation details  
- AOV's min clear opening 1.2m<sup>2</sup> to specialist details  
- 200mm Insulation & Details  
- Electrical layout & BS Smoke specification  
- Fire detection system identification & details throughout  
- Escape lighting specification & details & exit signage  
**IMPORTANT NOTE:**  
PLEASE REFER TO MITCHELL + ASSOCIATES DRAWINGS REPORT FOR LANDSCAPING DETAILS

**MATERIALS AND FINISHES:**

- 1- LIGHT BUFF BRICK
- 2- CONTRASTING DARK BRICK
- 3- METAL BALCONY COLOUR TO MATCH METAL GOODS
- 4- METAL GATE COLOUR TO MATCH METAL GOODS



**SOUTH ELEVATION**  
SCALE: 1 : 100

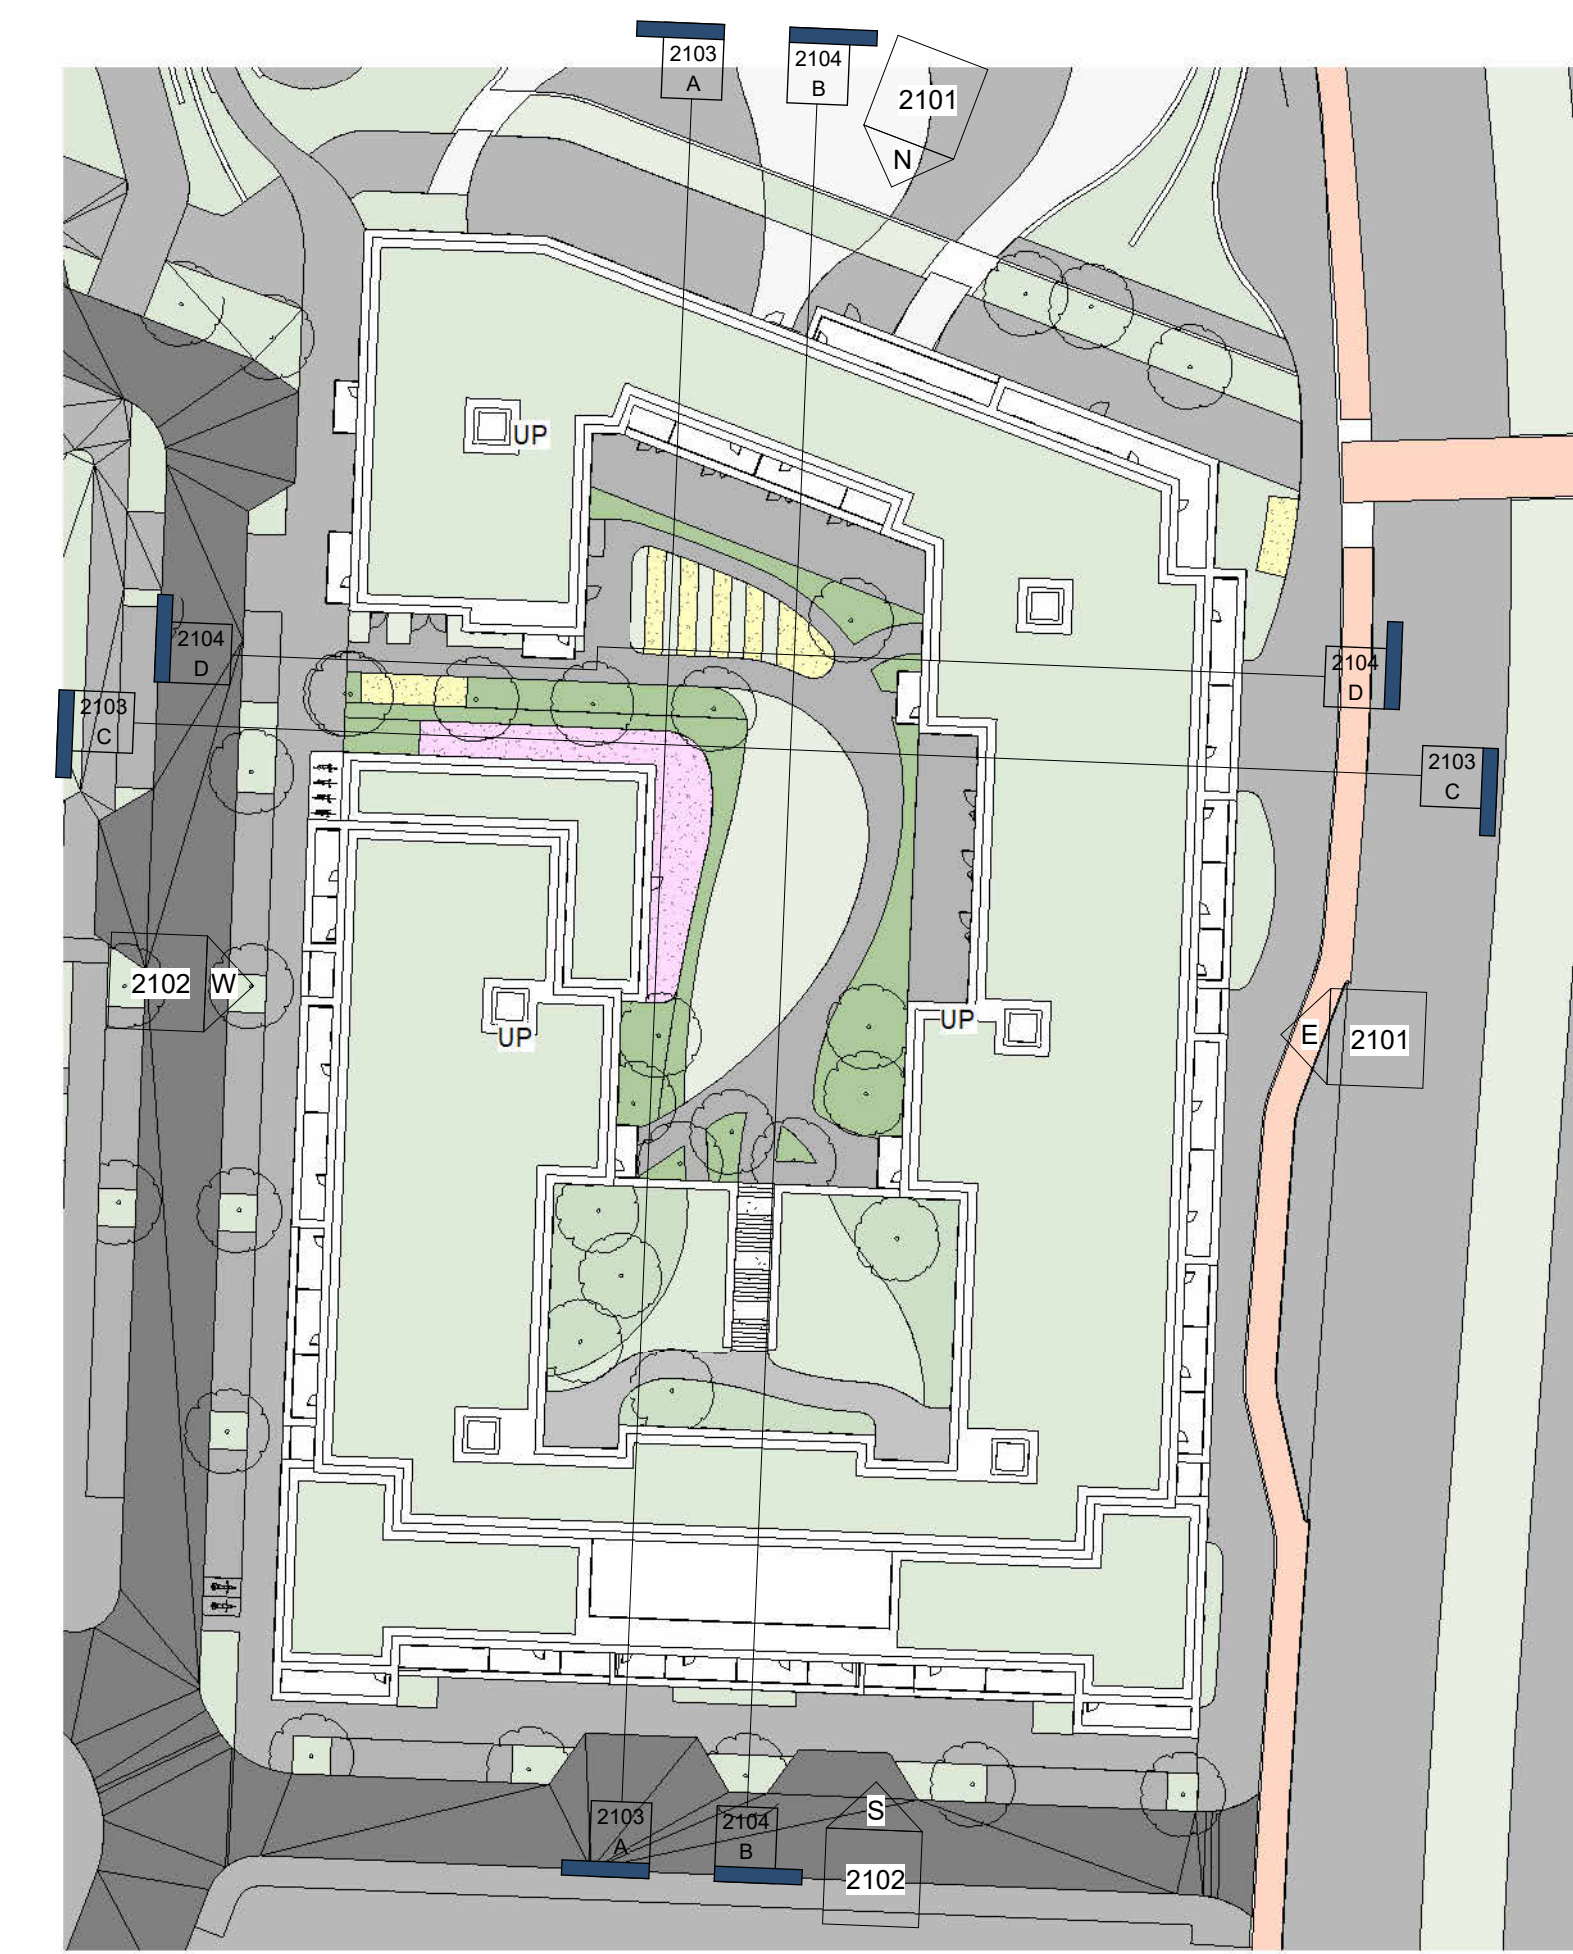

**WEST ELEVATION**  
SCALE: 1 : 100

REV	DATE	DESCRIPTION	ISSUED BY

**FOR PLANNING**

CLIENT:  
NDAFA On behalf of Dublin City Council  
PROJECT:  
SHB 5 BMD, Ballymun, Dublin 11  
DRAWING TITLE:  
**SITE 5- ELEVATIONS SHEET 02**

DESIGNER	DATE	SCALE	REVISED	NO.
JH	PMcN	1:100	28/06/2024	23004
DRAWING NUMBER:				STANDARD CODE:
SHB5-BMD-DR-MCORM-AR-P3-2102				P3

**MCORM**  
ARCHITECTURE  
AND URBAN DESIGN  
No. 1 Grantham Street, Dublin 8  
D08 A8Y7 Tel: +353 (0)1 478 8700  
Block & Central Business Park  
Tullamore, County Offaly  
433 1998 Tel: +353 (0)1 932 3807  
website: www.mcorm.com  
email: arch@mcorm.com

Figures dimensions only to be used. This drawing is copyright of MCORM Ltd. All information is shared as per approved use in accordance with I.S. 882:2017 or I.S. EN ISO 15852:2016. If 'Status Code' above is empty, this information has been drawn to Status Code 05 - Work in Progress (WIP) / Draft.