
 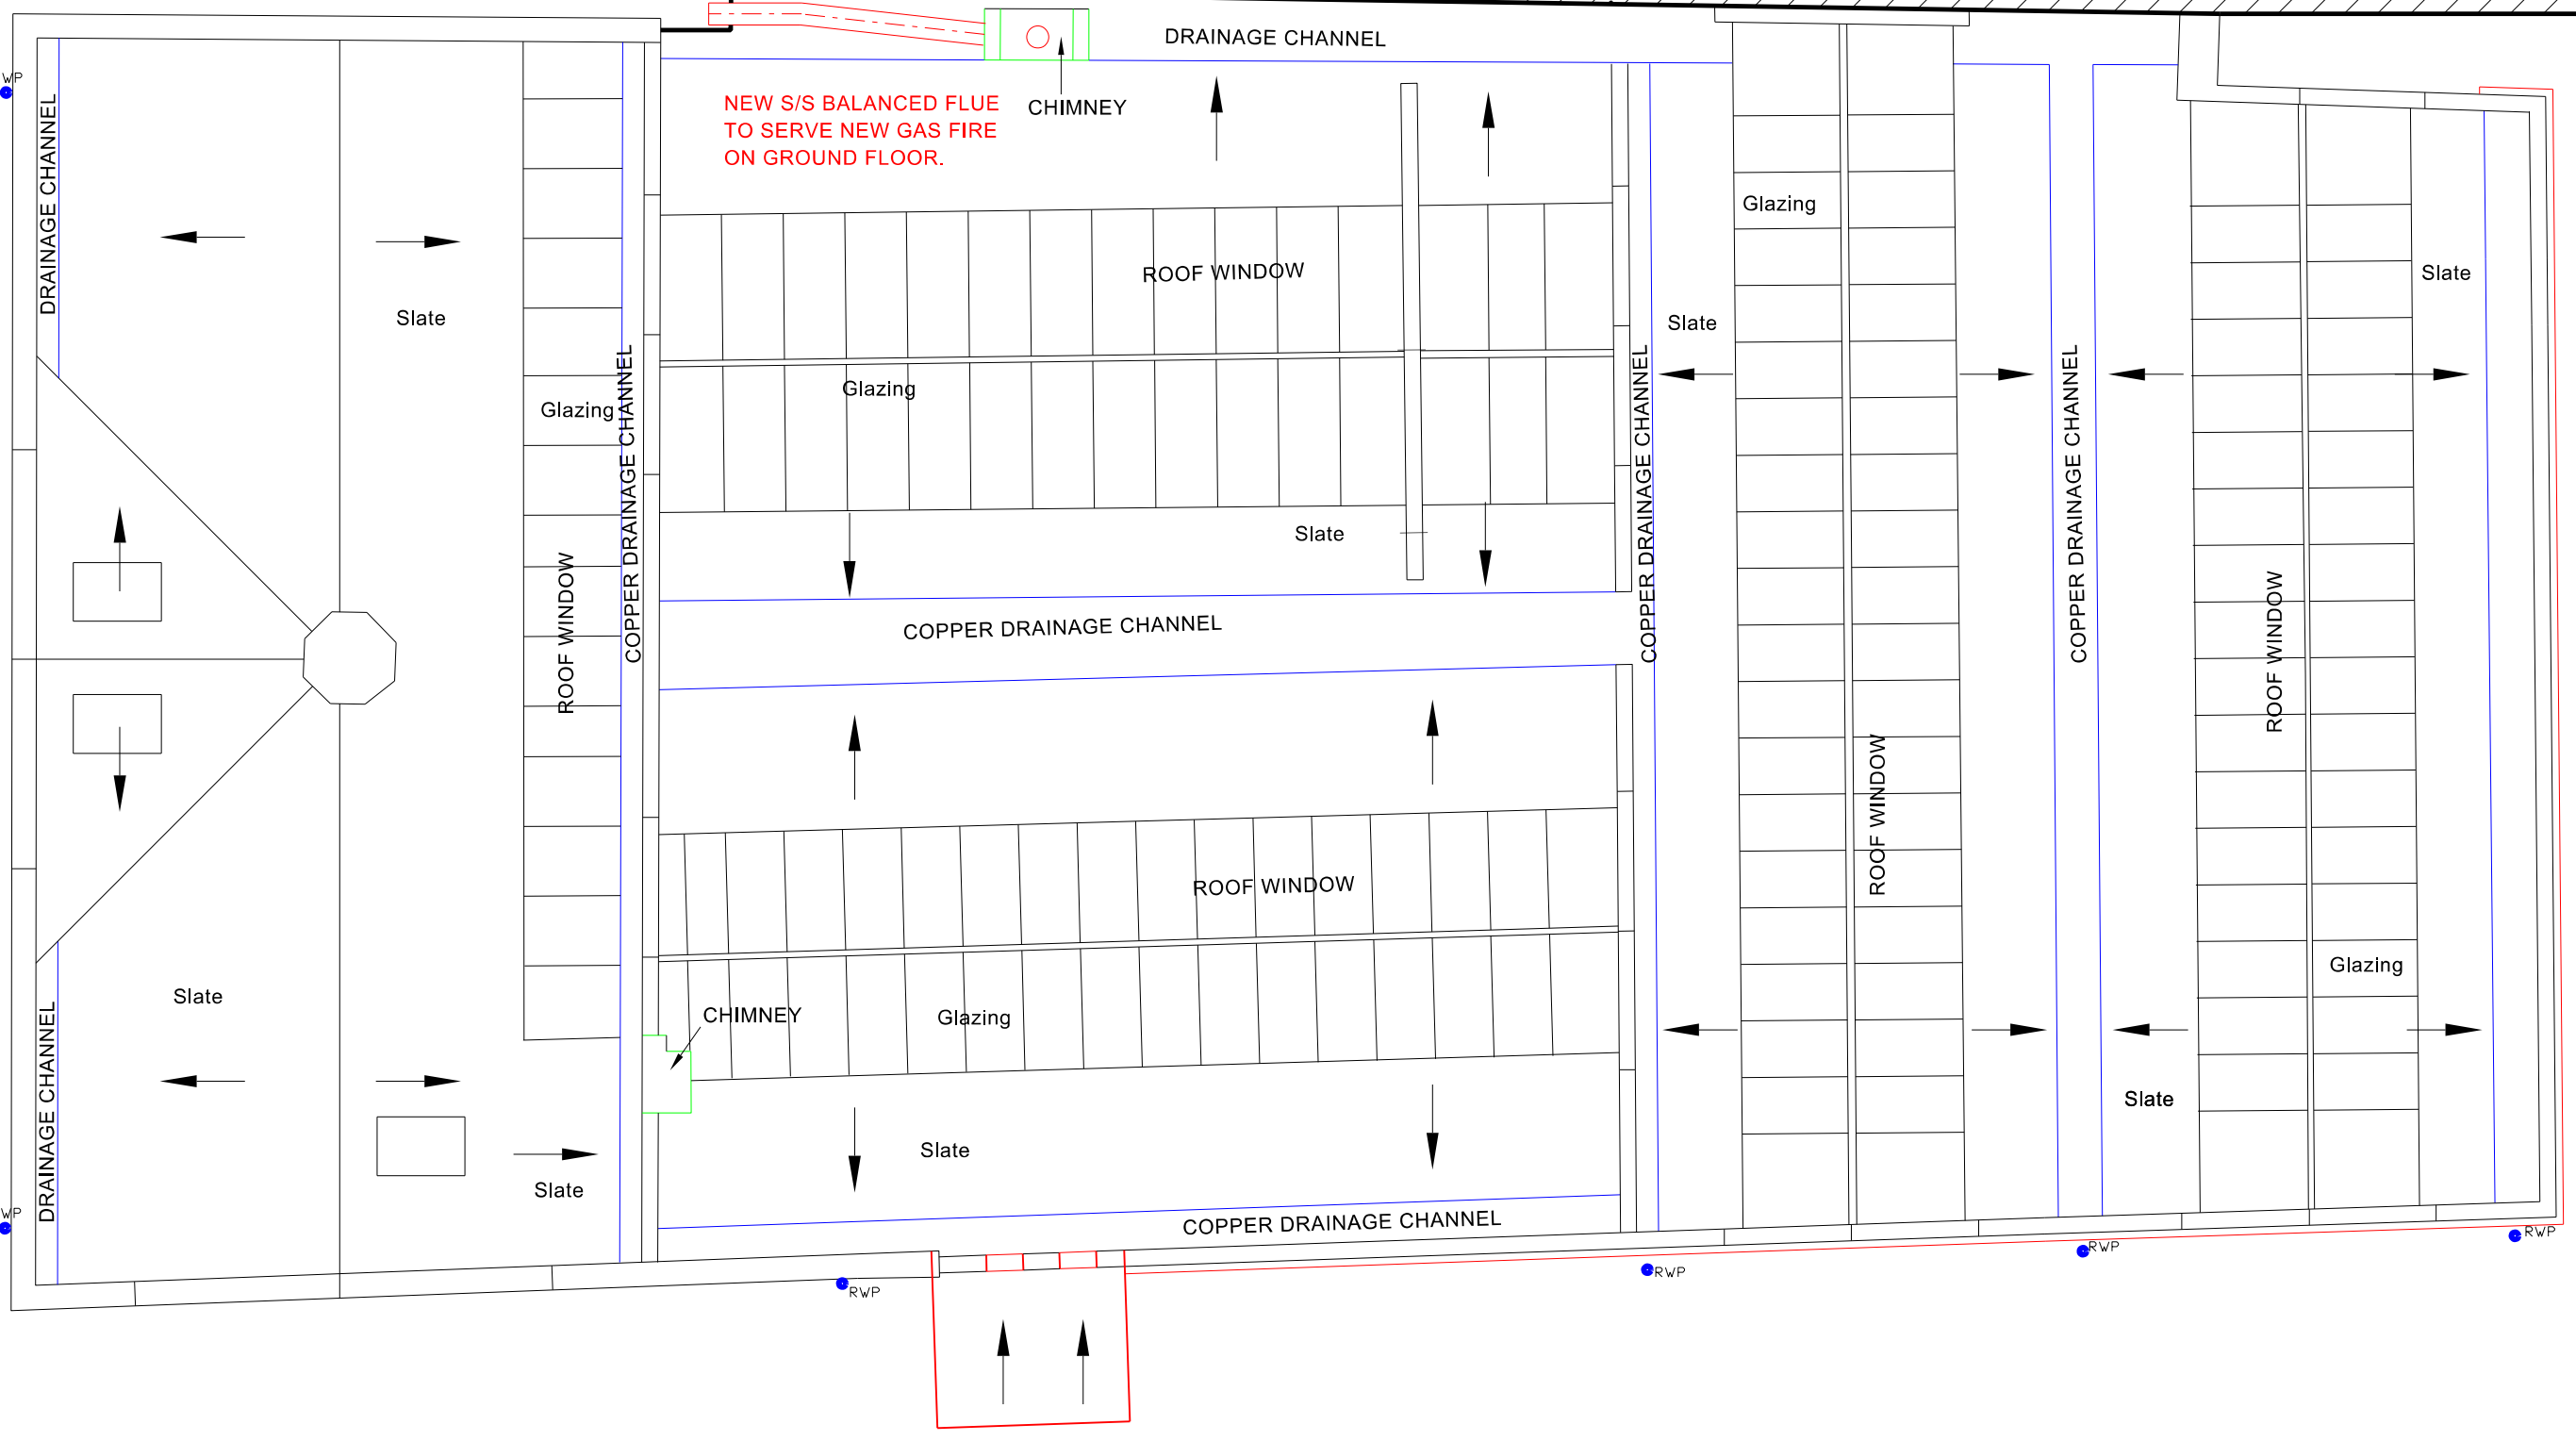


# D.I.T. COLLEGE

- IMPORTANT**
- DO NOT SCALE FROM THIS DRAWING.
  - WORK ONLY FROM FIGURED DIMENSIONS.
  - ALL ERRORS & OMISSIONS TO BE REPORTED TO THE ARCHITECT.
  - THIS DRAWING IS TO BE READ IN CONJUNCTION WITH ALL OTHER DRAWINGS IF IN DOUBT, ASK!



NEW S/S BALANCED FLUE TO SERVE NEW GAS FIRE ON GROUND FLOOR.

NEW POWDER COATED GAL/STEEL COPING TO BRICK PARAPET WITH EXTERNAL INSULATED RENDER TO MATCH REST OF FACADE. COPPER ROOF AT FALL TO DRAIN TO EXISTING COPPER GUTTER.

## ROOF PLAN

REV.	DATE	DESCRIPTION
-	-	-

STATUS KEY  
 SUR survey SKE sketch INF Information PLA planning  
 FSD fire safety TND tender CON construction FIN final

**Dublin City Council**  
 Comhairle Cathrach Bhaile Atha Cliath

**CITY ARCHITECTS DIVISION**  
 RÁNNÓG AILTIRE NA CATHRACH

CITY ARCHITECTS DIVISION, CMO OFFICES, WOOD QUAY, DUBLIN 8, IRELAND  
 www.dcc.ie/architects T. +353 (0)1 222 2222 F. +353 (0)1 222 2084

PROJECT TITLE: **KEVIN STREET LIBRARY**  
 Phase 2 Internal Refurbishment

PROJECT ARCHITECT: **D. MASTERSON** DATE: July 2014  
 PROJECT TEAM: **S. Dillon** SCALE: 1:100 @ A3

**PROPOSED ROOF PLAN**

PROJECT NO.	STATUS	DRAWING	REV.
CA-1051	-	212	-