


NOTES

- Notes

MH
6.58

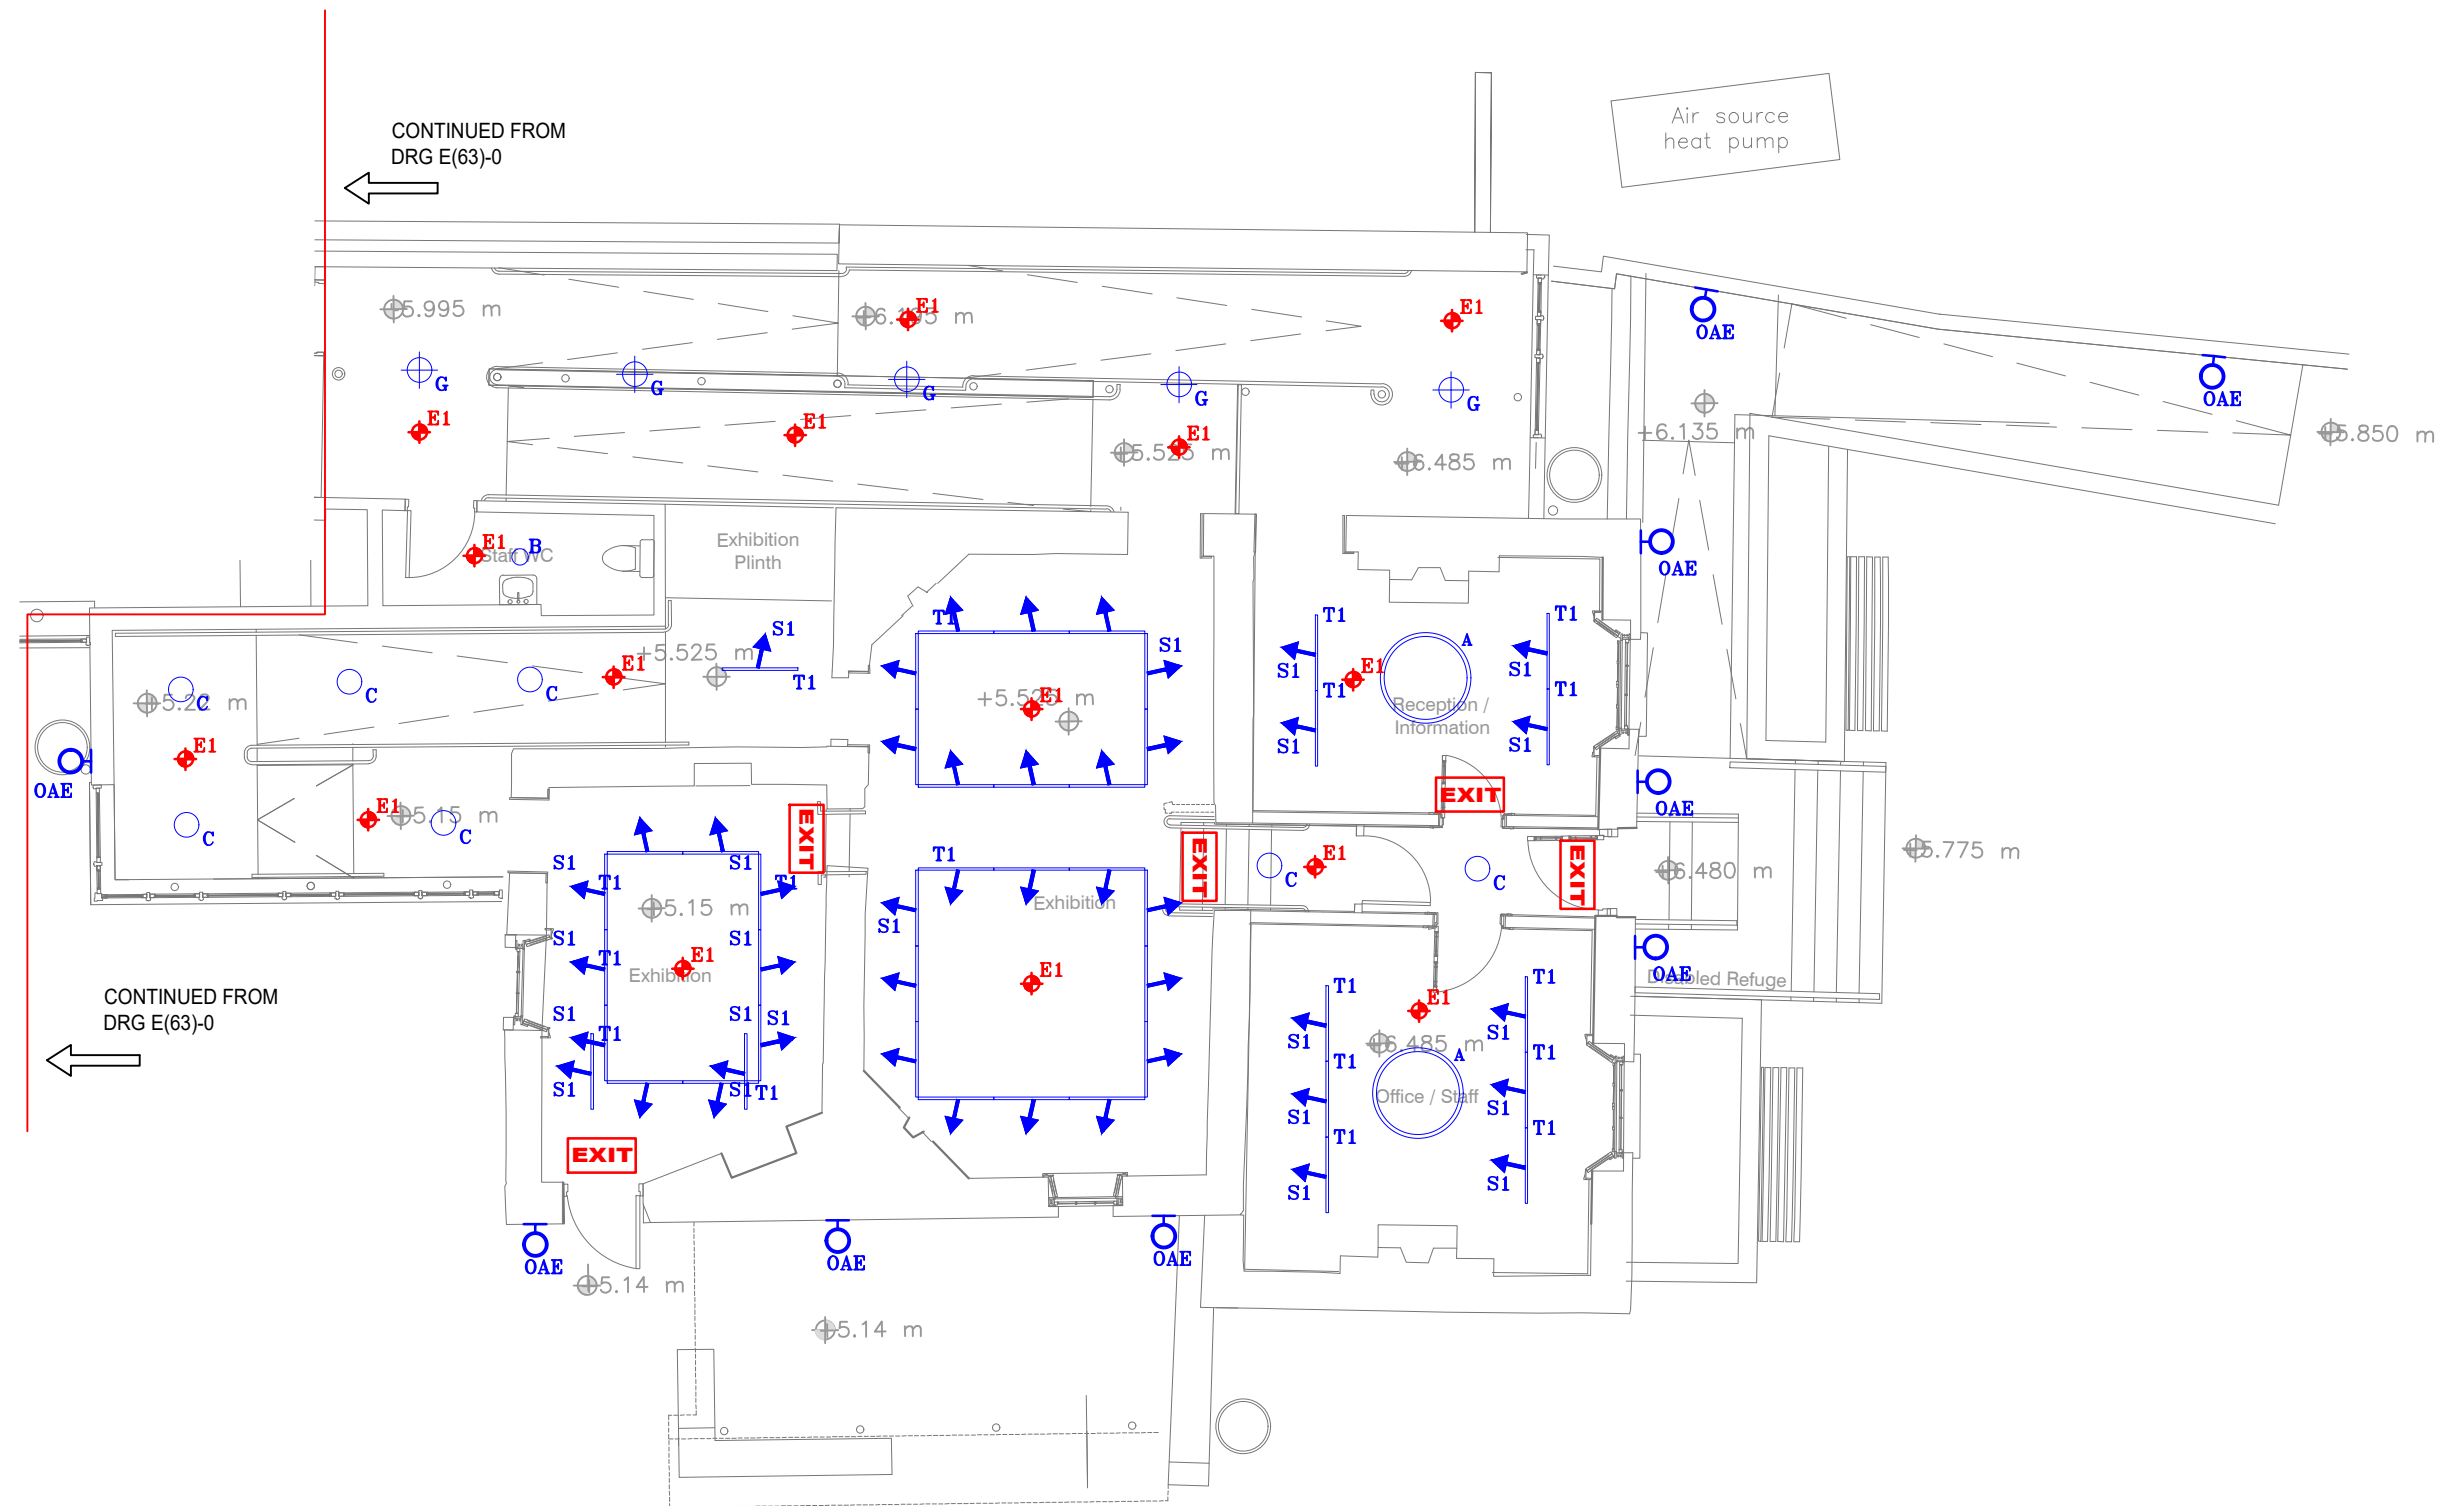

ref	by	chk	date	revision
-----	----	-----	------	----------


 Second Floor
 13 South Leinster Street
 Dublin 2
 Ireland
 t: +353 (0)1 678 7832
 www.finconsult.com
 info@finconsult.com

GLASGOW • DUBLIN • AYR • INVERNESS

Drg Status **PRELIMINARY**

Architect **BLACKWOOD ASSOCIATES**

Contract **COIS ABHANN LIFFEY VALE BIODIVERSITY CENTRE**

Title **PROPOSED LIGHTING LAYOUT GROUND FLOOR (2 of 2)**

Dwn	Date	Chk	Date
ADC	FEB 2021	DHR	

Scale 1:100 @ A3 (or as shown) Current Rev P1

JOB No. 3365

DRG. No. E[63]-02