

NOTES

1.

CHAPELIZOD ROAD

BUS


RG

MH 6.58

LP

ABOVE CAFE ROOF

Air source heat pump

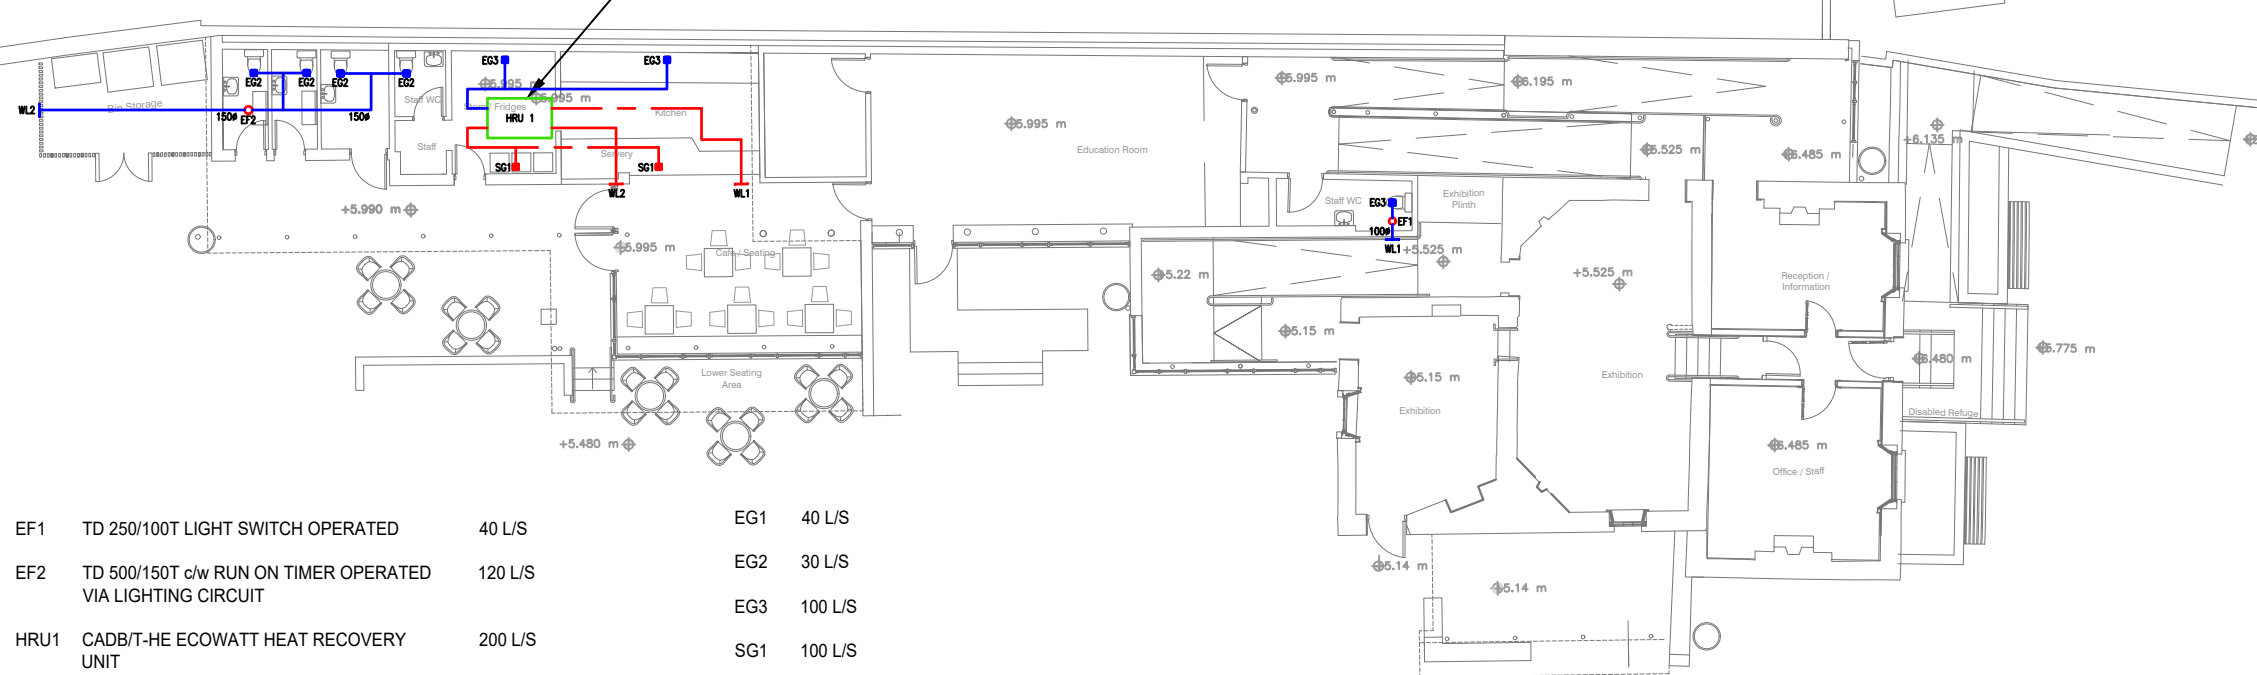

EF1	TD 250/100T LIGHT SWITCH OPERATED	40 L/S	EG1	40 L/S
EF2	TD 500/150T c/w RUN ON TIMER OPERATED VIA LIGHTING CIRCUIT	120 L/S	EG2	30 L/S
HRU1	CADB/T-HE ECOWATT HEAT RECOVERY UNIT	200 L/S	EG3	100 L/S
			SG1	100 L/S

ref	by	chk	date	revision
P2	ADC	DGA	03/11/21	MODIFIED TO REFLECT NEW LAYOUT.


 Second Floor
 13 South Leinster Street
 Dublin 2
 Ireland
 t: +353 (0)1 678 7832
 www.flnconsult.com
 info@flnconsult.com

GLASGOW • DUBLIN • AYR • INVERNESS

Drg Status **PRELIMINARY**

Architect **BLACKWOOD ASSOCIATES**

Contract **COIS ABHANN LIFFEY VALE BIODIVERSITY CENTRE**

Title **PROPOSED VENTILATION LAYOUT GROUND FLOOR**

Drn	Date	Chk	Date
ADC	FEB 2021	DGA	

Scale 1:200 @ A3 (or as shown) Current Rev P2

JOB No. 3365

DRG. No. F[57]-100