

DRG. No. M[57]-101


Notated dimensions and/or levels to be used only. All dimensions and/or levels must be site checked by the Contractor prior to commencing any construction work. Any discrepancies must be reported to the Engineer. No assumptions are to be made regarding this drawing.

IMPORTANT : DO NOT SCALE FROM THIS DRAWING

This drawing is the copyright of FLN Consulting Engineers and must not be copied or reproduced without prior permission.

**NOTES**

1. THIS DRAWING TO BE READ IN CONJUNCTION WITH ALL OTHER DRAWINGS AND DOCUMENTATION INCLUDED IN CONTRACT
2. DRAWING IS NOT TO SCALE.
3. LAYOUTS SHOWN ARE INDICATIVE ONLY, AND SHOULD BE CONFIRMED WITH ARCHITECTURAL LAYOUTS.

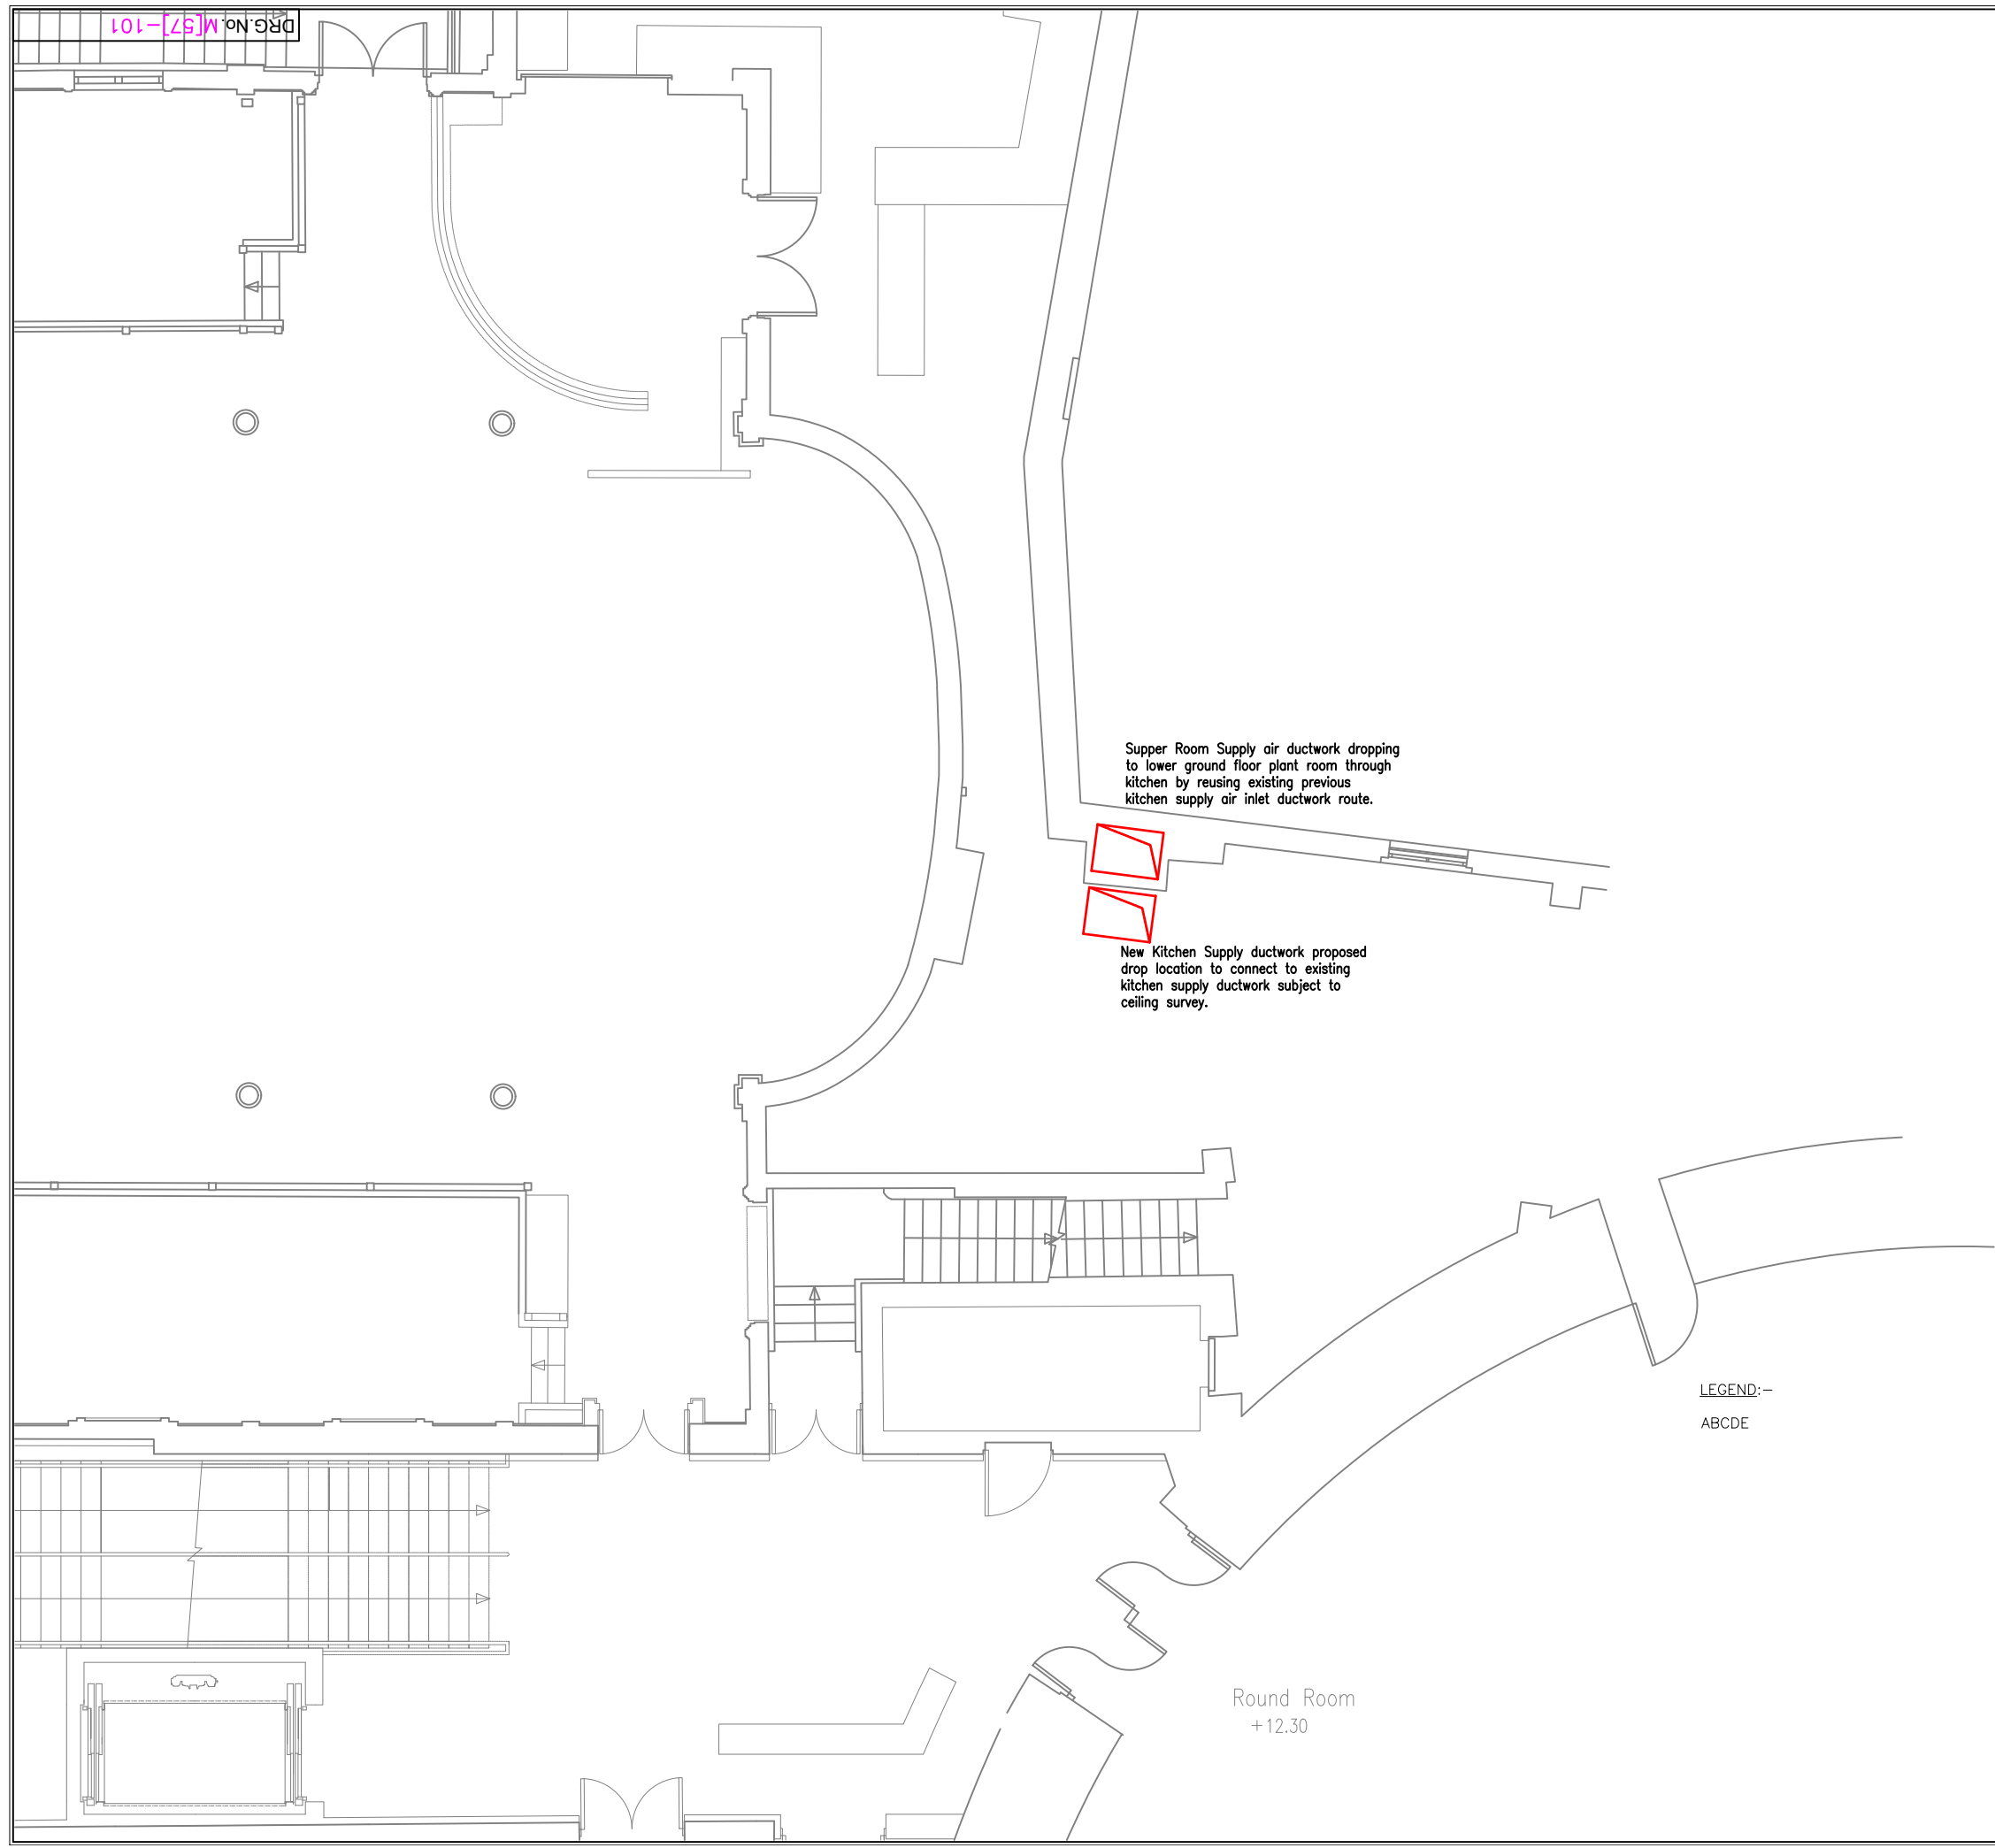


Supper Room Supply air ductwork dropping to lower ground floor plant room through kitchen by reusing existing previous kitchen supply air inlet ductwork route.



New Kitchen Supply ductwork proposed drop location to connect to existing kitchen supply ductwork subject to ceiling survey.

LEGEND: -  
ABCDE

Round Room  
+12.30

ref	by	chk	date	revision
 <p>Second Floor 13 South Leinster Street Dublin 2 Ireland t: +353 (0)1 678 7832 www.flnconsult.com info@flnconsult.com</p> <p>GLASGOW • DUBLIN • AYR • INVERNESS</p>				
Drg Status				PART 8 SUBMISSION
Architect				Blackwood Associates Architects
Contract				MANSION HOUSE DUBLIN 2
Title Proposed Ventilation System Comprising Kitchen Supply Air Only and Supper Room Heat Recovery AHU – Upper Ground Floor Part 8 Planning Application				
Drn	Date	Chk	Date	
DGA	19.04.2023	DGA	19.04.2023	
Scale 1:100 @ A3			(or as shown)	Current Rev S1
JOB No.				3416
DRG. No.				M[57]-101