


BRIDGE – NORTH ELEVATION
SCALE 1:500

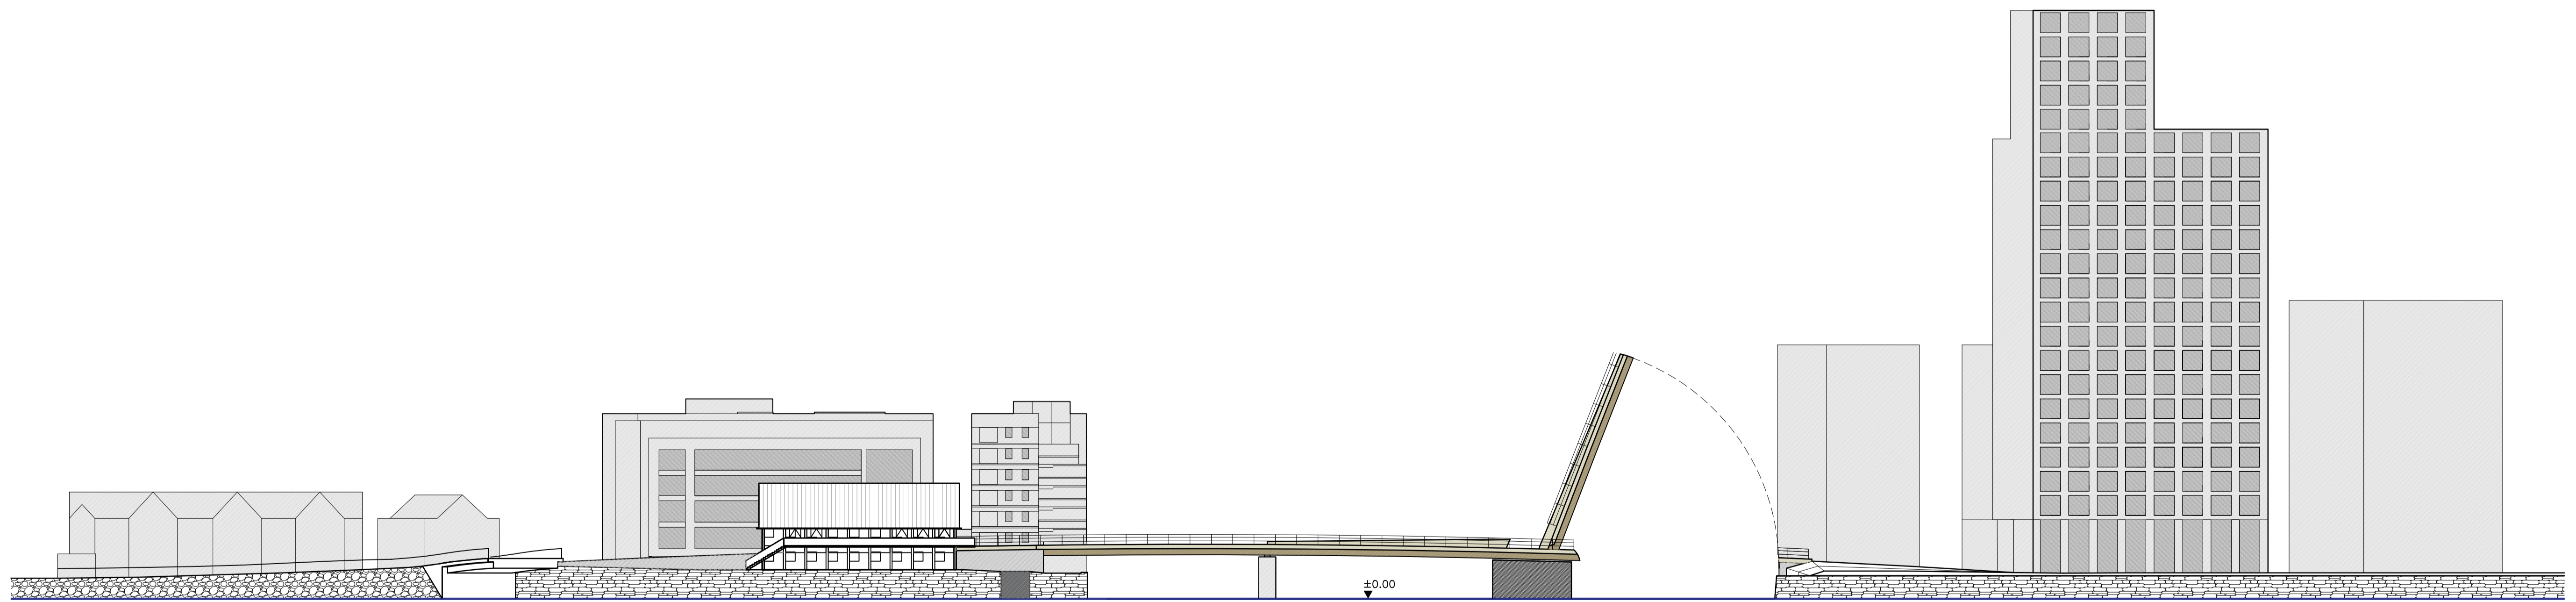

BRIDGE – NORTH ELEVATION
SCALE 1:500



Michel Virlogeux Consultant SARL
24, RUE DE LA DIVISION LECLERC
78830 BONNELLES
Mobile : 06 14 24 35 90
Fax : 01 30 88 43 44

SEÁN HARRINGTON ARCHITECTS

No.	Revision	Date	By	Chk'd	App'd



Arena House, Arena Road, Sandyford, Dublin 18, Ireland
t +353 (0) 1 294 0800
f +353 (0) 1 294 0820
www.rod.ie

Consulting Engineers
Civil - Structural - Transportation - Environmental

Drawn	Designed	Checked	Approved	Suitability Code - Description
PE	CS	JK	TD	S0 - Work In Progress

Project Title	DODDER PUBLIC TRANSPORTATION OPENING BRIDGE							
Drawing Title	OUTLINE SCHEME PROPOSALS SHEET 2							
Drawing Number	Project	Originator	Volume	Location	Type	Role	Number	
	DPTB	ROD	C1	SWE	DRG	EN	00104	
Scale (A1)	AS SHOWN	Date:	JAN 2018	Job No:	17143	Rev:	01	