


IMPORTANT
DO NOT SCALE FROM THIS DRAWING. WORK ONLY FROM FIGURED DIMENSIONS. ALL ERRORS & OMISSIONS TO BE REPORTED TO THE ARCHITECT. THIS DRAWING IS TO BE READ IN CONJUNCTION WITH ALL OTHER DRAWINGS AND SPECIFICATIONS. THE NAMES OF PREMISES INDICATED ARE CORRECT AS FAR AS CAN BE DETERMINED. THE NAMES OF THESE PREMISES MAY CHANGE OR MAY HAVE CHANGED PRIOR TO COMMENCEMENT OF WORKS.

Includes Ordnance Survey Ireland data reproduced under OS Licence number 2020/23/CMA/DublinCityCouncil. Unauthorised reproduction infringes Ordnance Survey Ireland and Government of Ireland copyright. © Ordnance Survey Ireland, 2021

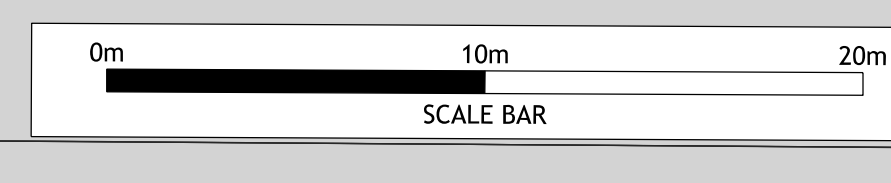

Legend

Part 8 Boundary	
Proposed High Level Horizontal Feature Lighting Installation	
Proposed Vertical Feature Lighting Installation	

Notes:
- Drawing relates to feature lighting only, does not relate to DCC Public Lighting
- All lighting details and potential fixings subject to agreement of property owners.

B	06.12.2022	Part 8 Planning
A	16.09.2022	Pre-Part 8 Internal Circulation
VER	DATE	DESCRIPTION
ISSUE STATUS KEY		
PREL-F	Preparation	PREL-F
PREL-P	Preparation	PREL-P
PREL-A	Preparation	PREL-A
PREL-T	Preparation	PREL-T
PREL-S	Preparation	PREL-S
PREL-E	Preparation	PREL-E
PREL-R	Preparation	PREL-R
PREL-O	Preparation	PREL-O
PREL-I	Preparation	PREL-I
PREL-D	Preparation	PREL-D
PREL-U	Preparation	PREL-U
PREL-L	Preparation	PREL-L
PREL-M	Preparation	PREL-M
PREL-N	Preparation	PREL-N
PREL-X	Preparation	PREL-X
PREL-Y	Preparation	PREL-Y
PREL-Z	Preparation	PREL-Z

Comhairle Cathrach Bhaile Átha Cliath Dublin City Council

CITY ARCHITECTS DIVISION

PROJECT TITLE: Duke St. Anne St South Public Realm Scheme

PROJECT ARCHITECT: J. McGovern

PROJECT TEAM: L. Morrissey

DATE: April 2017

SCALE: 1:200

DRAWING TITLE: Proposed Feature Lighting Plan

REFERENCE NO.: CA17010 PLAN-F

ISSUE STATUS: PREL-F

DWG. NO.: 29-B

VER: B